



5			DR'N BY: JOE D.	Queen's University Physical Plant Services		
4			DATE: MAY/91			
3			APP'D BY:	DUNNING HALL		
2	JUNE 2004	UPDATE FOR VFM	SCALE: AS SHOWN			
1	SEP'00	ADD RMS 9A, 9B REVISE RM 11 & 20	FILE NO. 130	BLDG. No. 130	BLOCK	C.A.D.D. REF. 130-00
0	DATE	REVISION	DWG. 1 OF 5	PROJECT No. / FILE No. 130	DRAWING No. A001	REV. 2

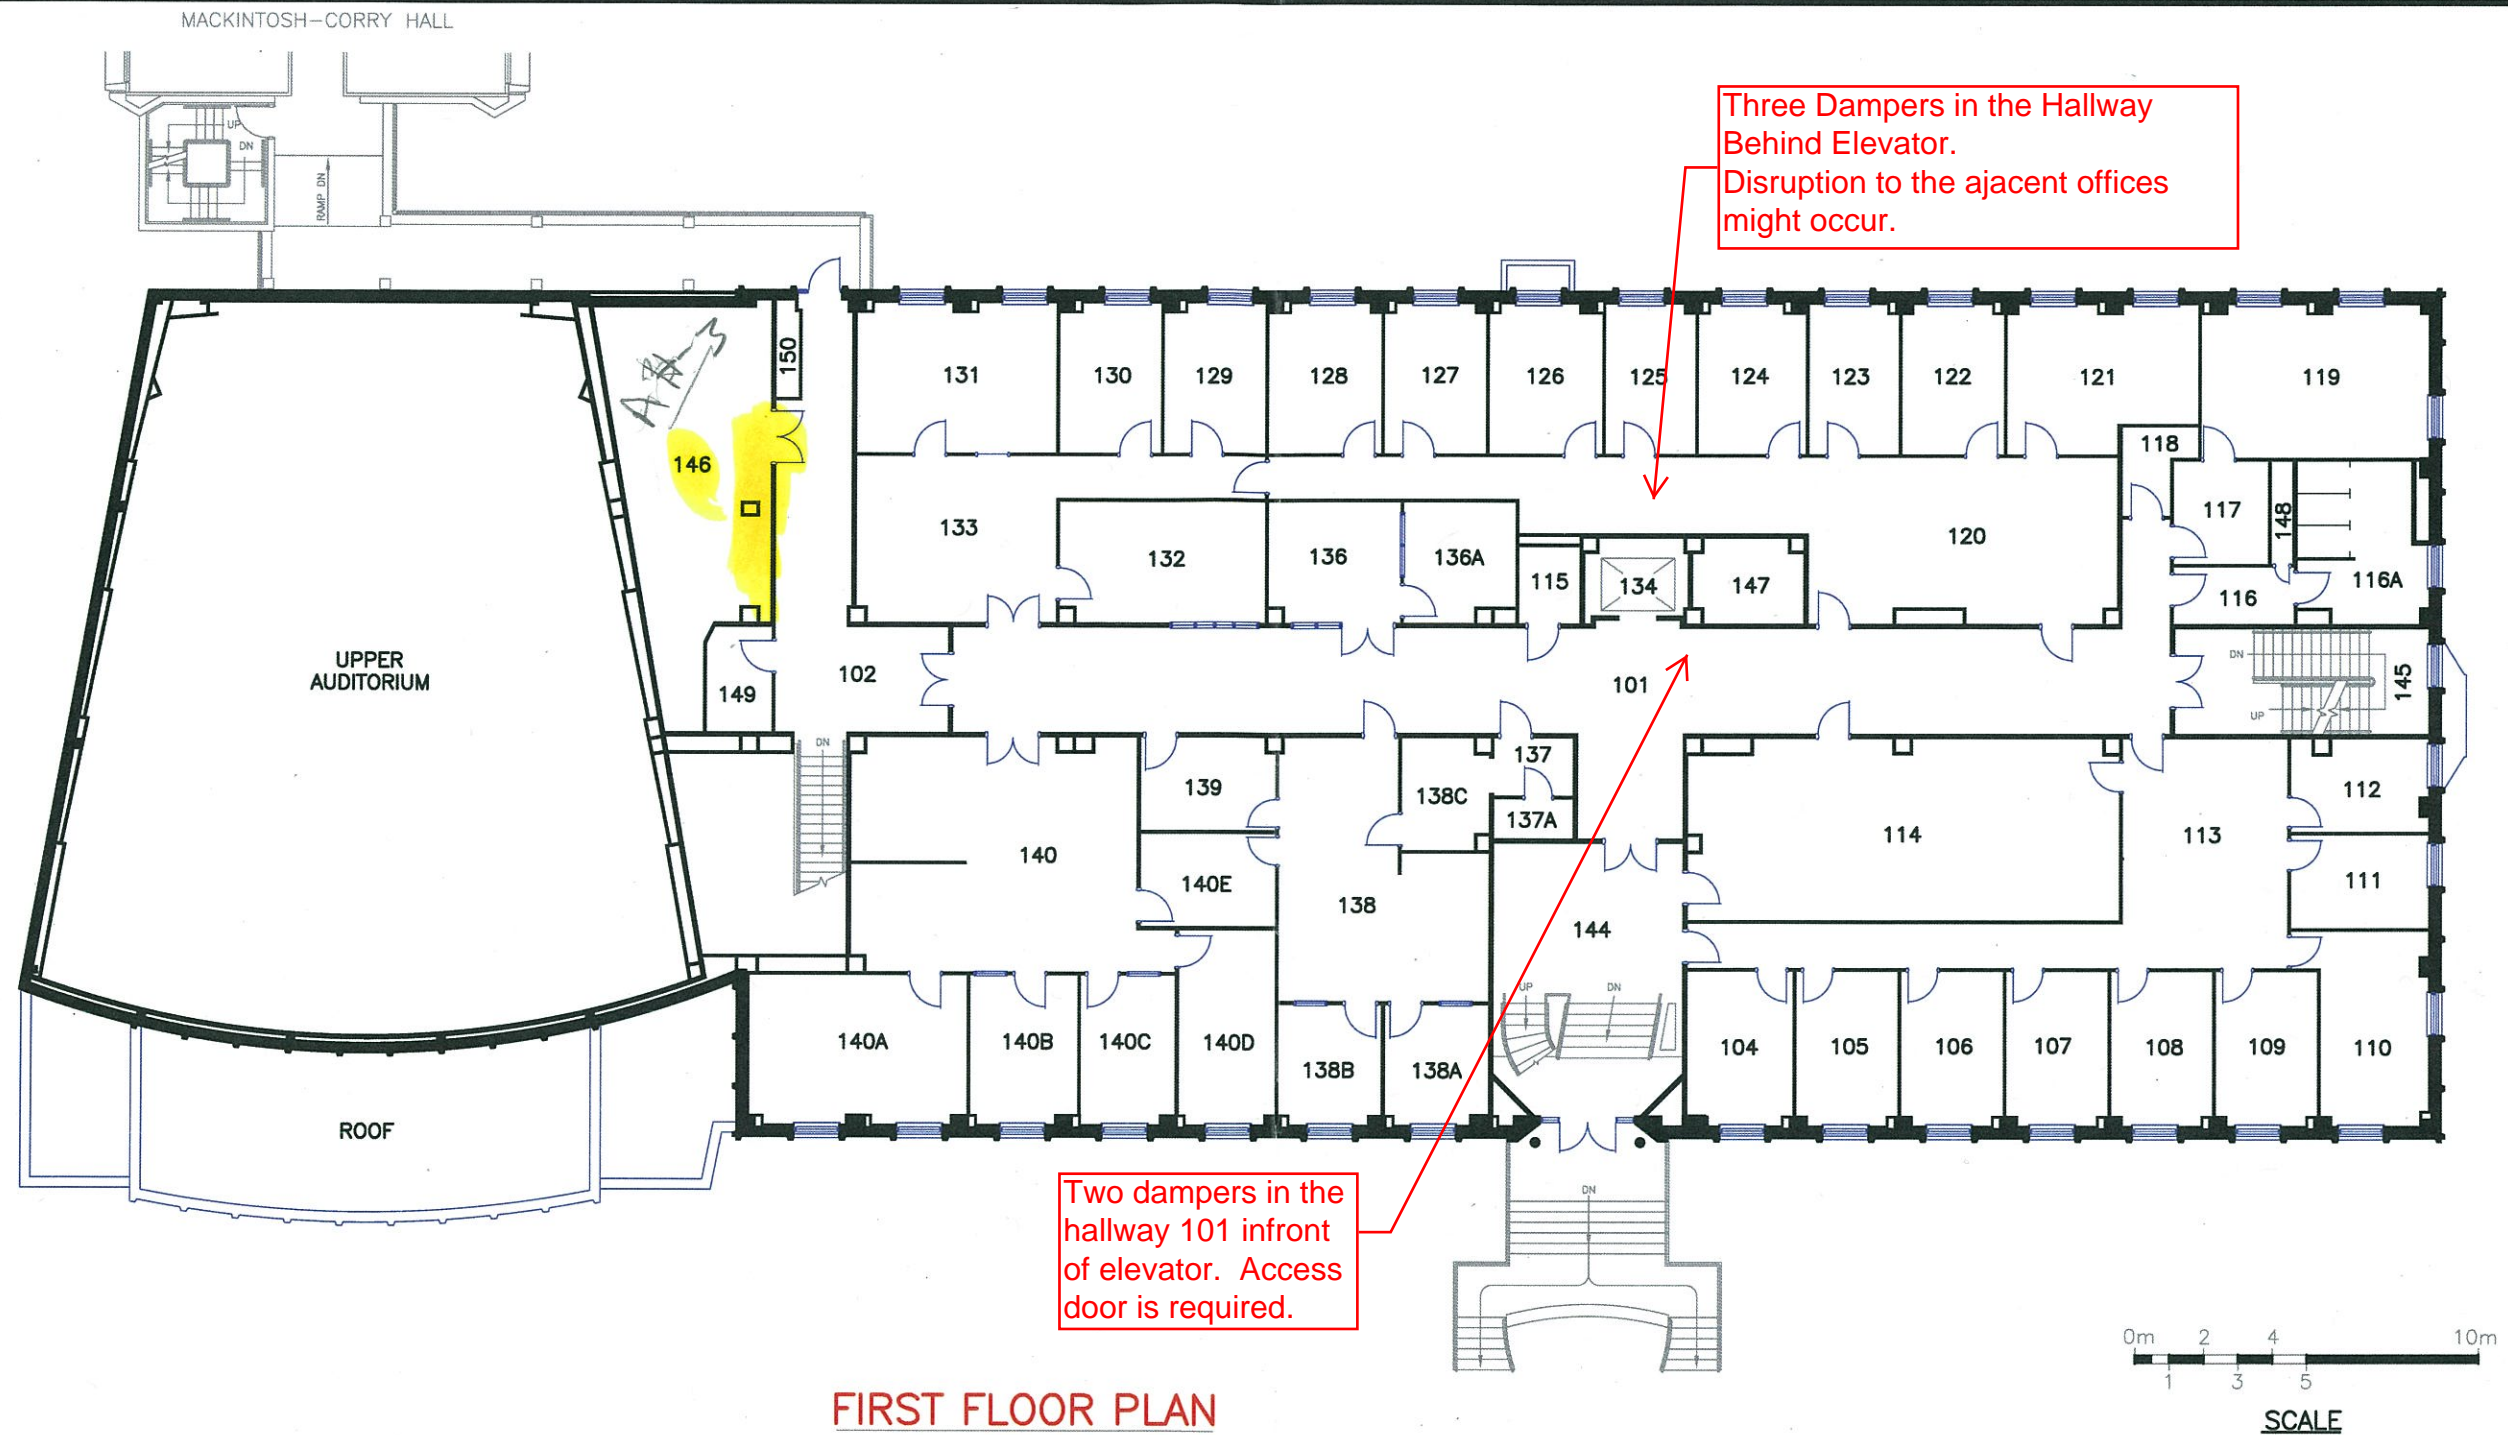

FIRST FLOOR PLAN

5			DR'N BY: JOE D.	Queen's University Physical Plant Services		
4			DATE: MAR/92			
3	JUNE 2004	UPDATE FOR VFM	APP'D BY:	DUNNING HALL		
2	NOV'03	REVISE RMS 131, 132, 136	SCALE: AS SHOWN			
1	MAR'99	ADD RMS 138A, 138B, 139 140E	FILE NO. 130	BLDG. No. 130	BLOCK LEVEL L1	C.A.D.D. REF. 130-01
0	DATE	REVISION	DWG. 2 OF 5	PROJECT No. / FILE No. 130		DRAWING No. A002
						REV. 3

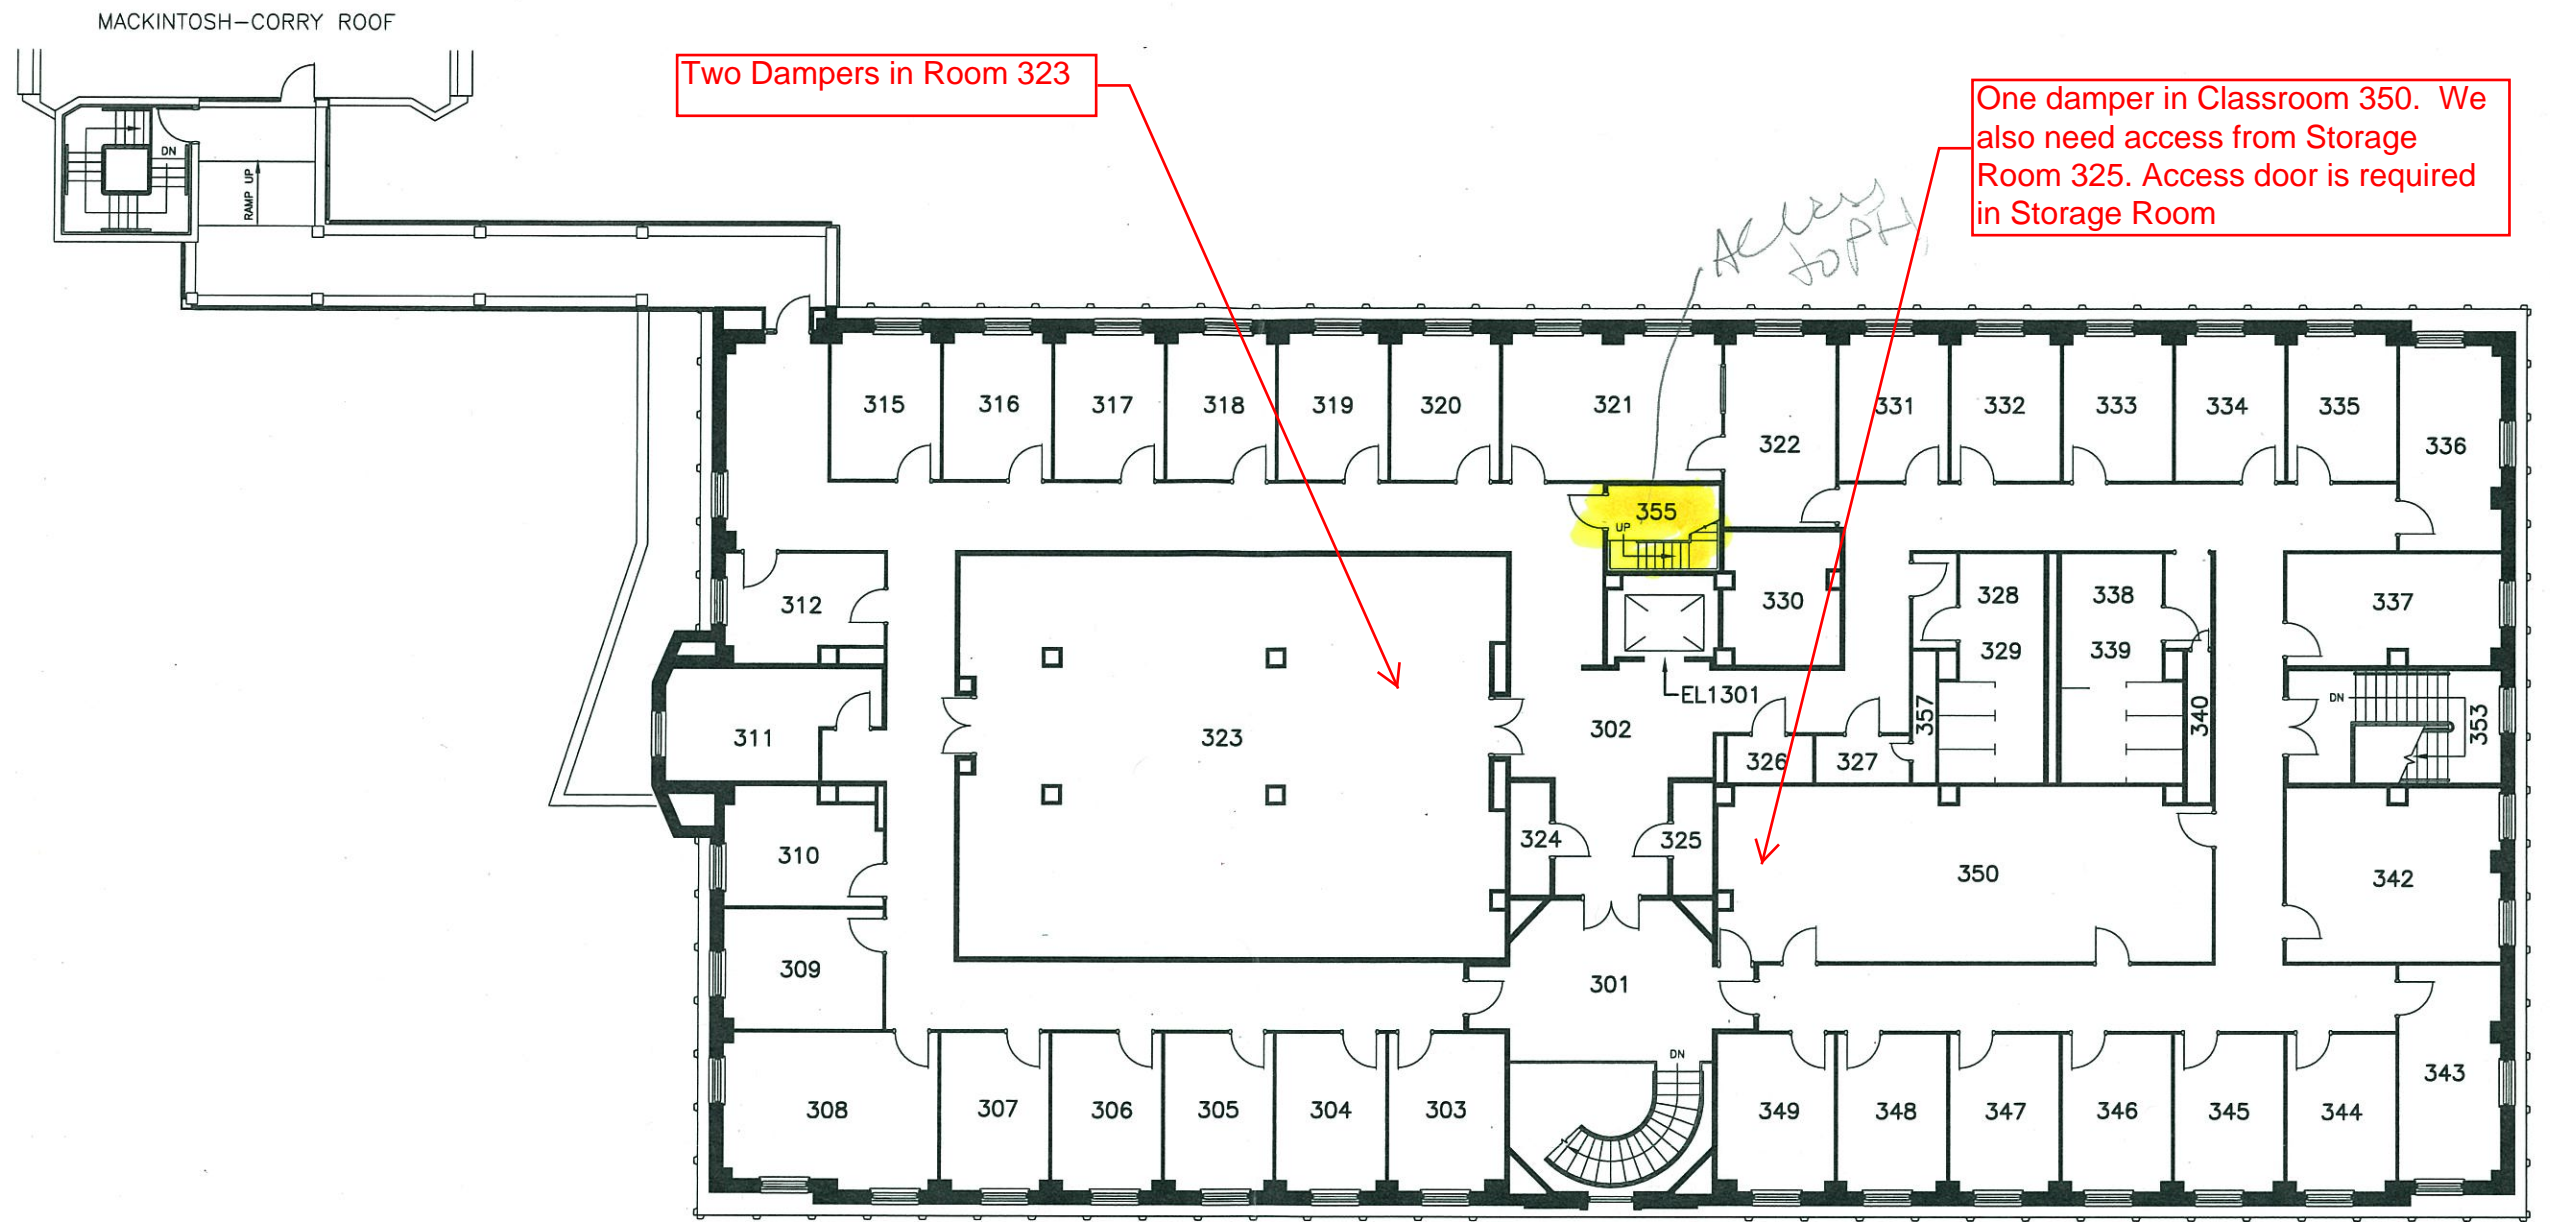

THIRD FLOOR PLAN

5			DR'N BY: JOE D.	Queen's University Physical Plant Services			
4			DATE: APRIL/92				
3			APP'D BY:	DUNNING HALL			
2	JUNE 2004	UPDATE FOR VFM	SCALE: AS SHOWN				
1	JAN/95	DELETE ROOM 351	FILE NO. 130	BLDG. No. 130	BLOCK	LEVEL L3	C.A.D.D. REF. 130-03
0	DATE	REVISION	DWG. 4 OF 5	PROJECT No. / FILE No. 130		DRAWING No. A004	REV. 2

